


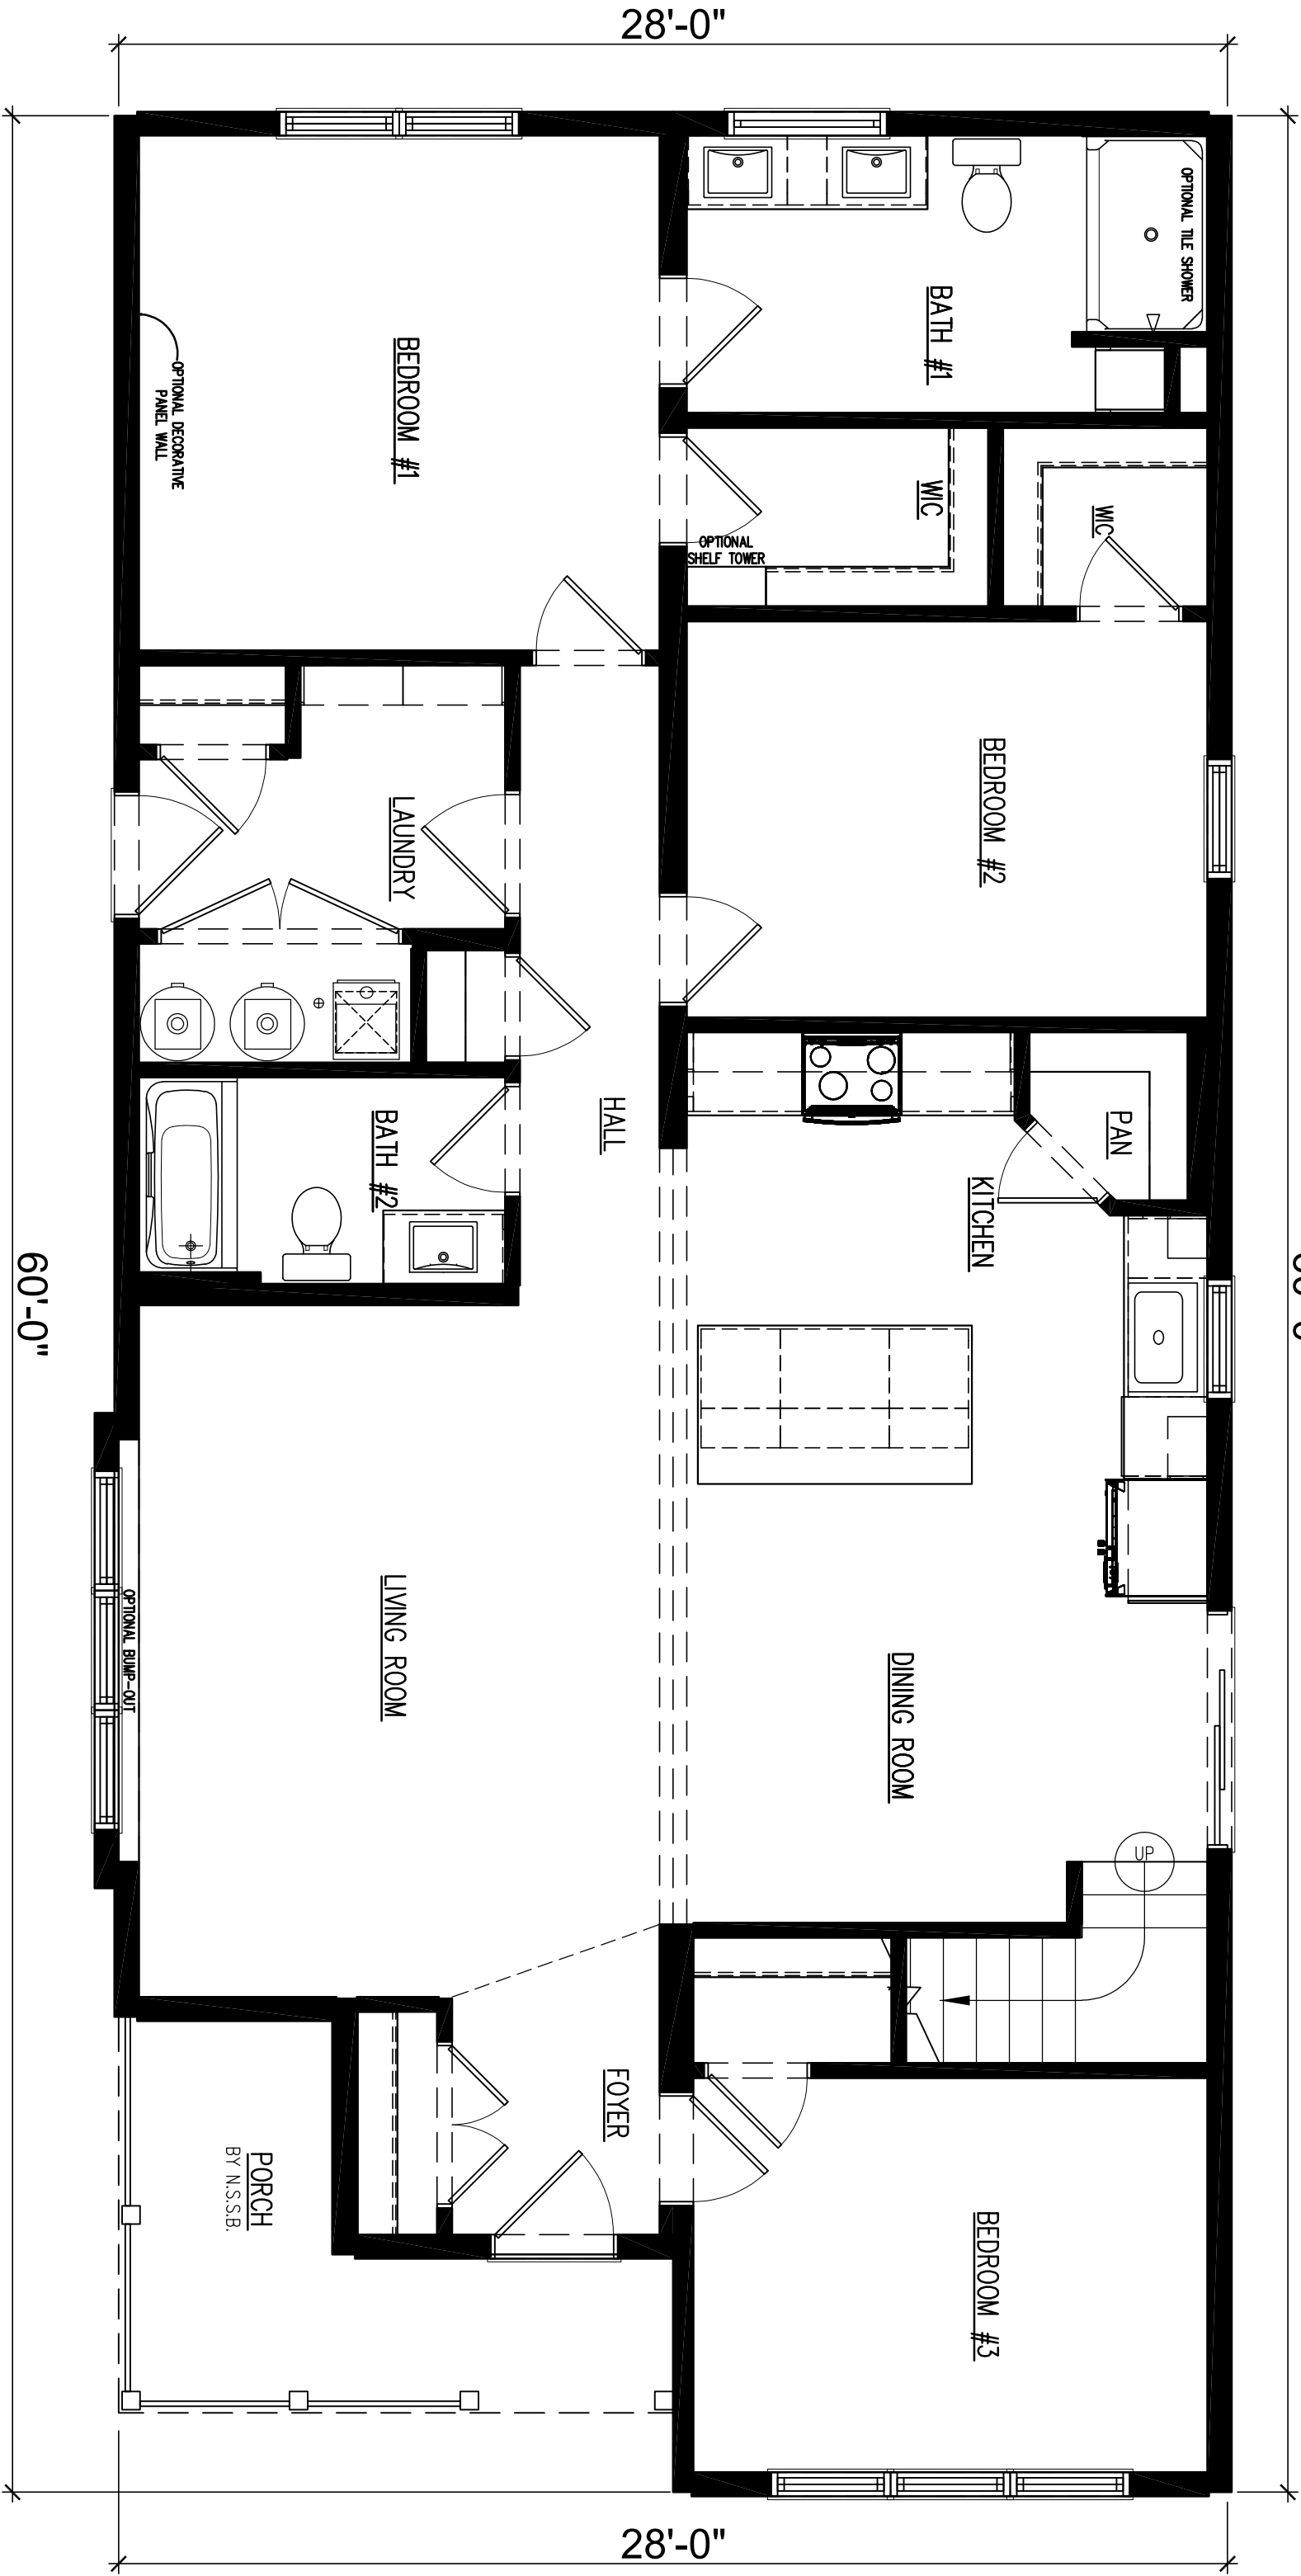

NORTHSTAR
SYSTEMBUILT

203 Industrial Drive
Redwood Falls, MN
Ph: (507) 644-6600
Fx: (507) 644-6601

MAIN LEVEL FLOOR PLAN

NSXXXX	DEALER: NORTHSTAR SYSTEMBUILT
DRAWN BY: X	CUSTOMER: MARSHALL
DATE: 2025	REV: X BY: X DATE: X
SCALE: 1/4" = 1'-0"	

PAGE:

A 1 . 1